


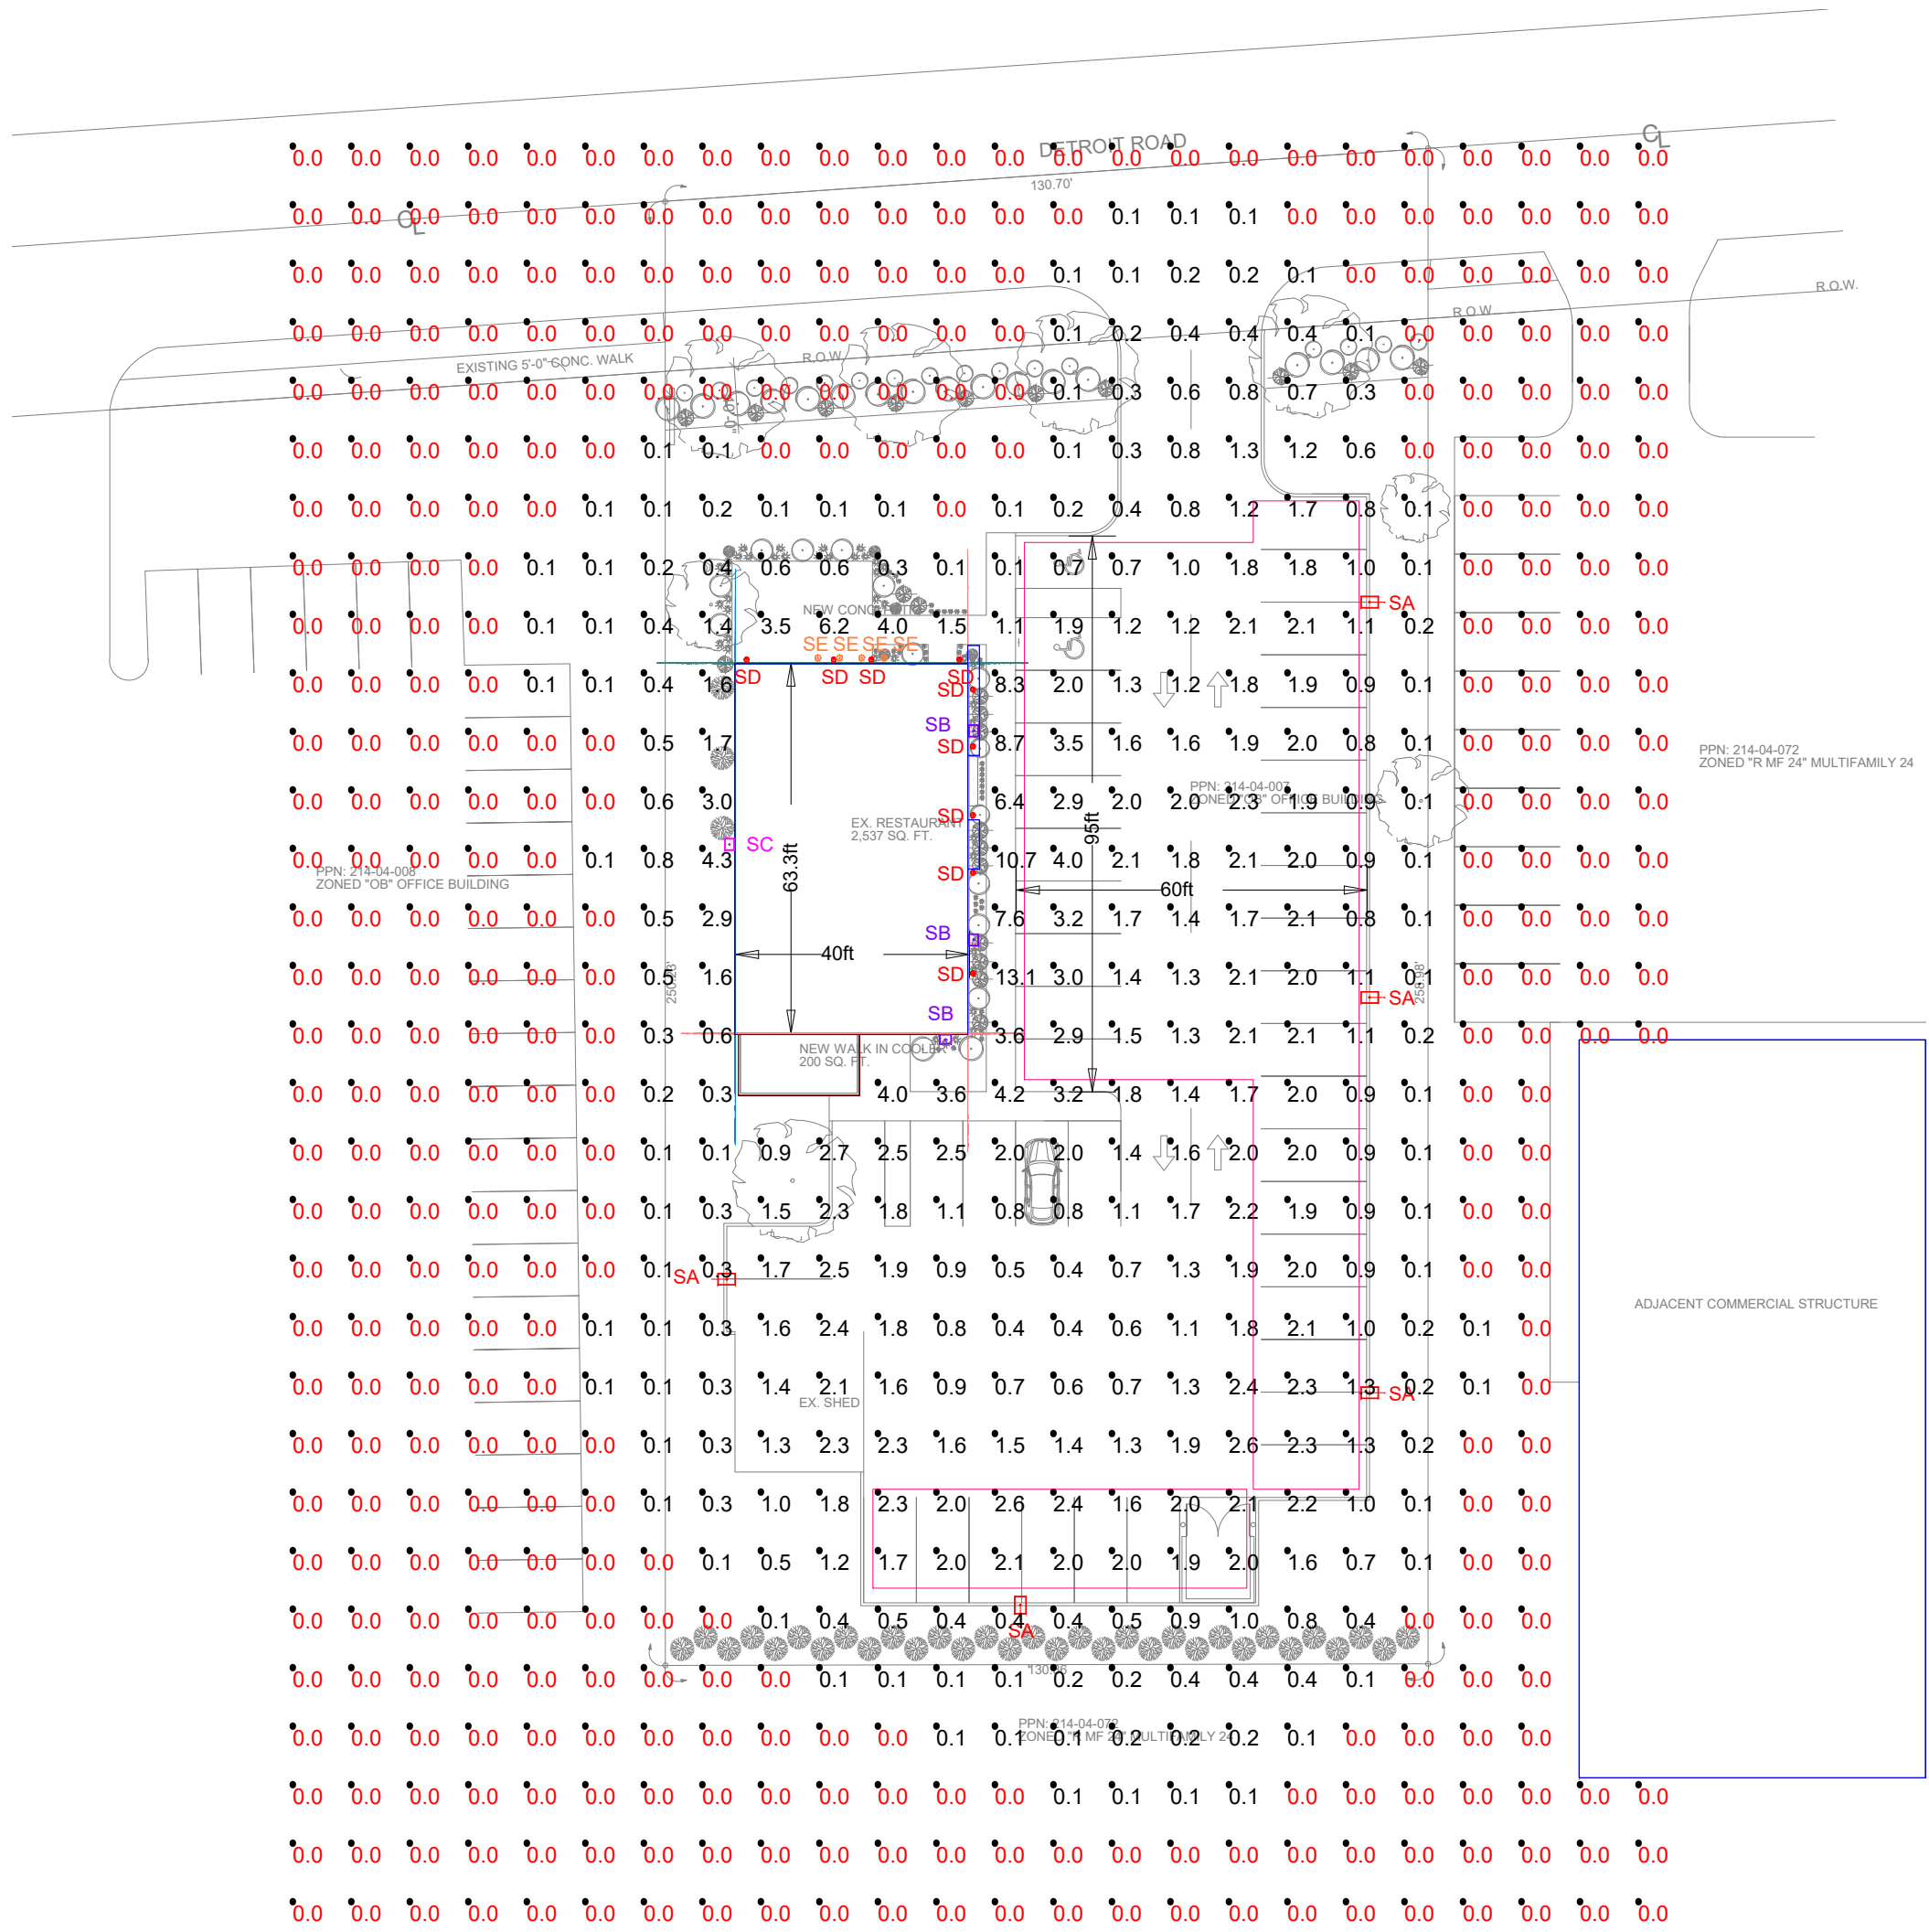

Luminaire Schedule								
Symbol	Qty	Label	LLF	Luminaire Lumens	[MANUFAC]	Description	Filename	Mounting Height
	5	SA	0.900	5011	BEACON PRODUCTS	VP-SS-1-40L-80-3K7-4W-UNV-A-DBT-MBC-SSAB16-40A-1-XX-DBT-VM2	VP-SS-1-40L-80-3K7-4W-MBC.ies	18
	3	SB	0.900	4559	BEACON PRODUCTS	VPW-SS-2-20L-30-3K7-4W-UNV-DBT	VPW2-SS-20L-30-3K7-4W.ies	11
	1	SD	0.900	2946	BEACON PRODUCTS	VPW-SS-2-20L-20-3K7-2-UNV-DBT	VPW2-SS-20L-20-3K7-2.ies	11
	9	SD	0.900	1210	ARCHITECTURAL AREA LIGHTING	PROS-Y3-2530K8-WMA59U-DBT-LDL	PROS-Y3-2030-LDL.ies	5
	4	SE	0.900	1049	Spectrum Lighting	AR1214GV-15L-35K-EX-TF1-CP104-PA23-XX-WLKA	SP-00326_4 ~ AR1214GV-15L35K-EXTF1-MWL.ies	12.7

Calculation Summary							
Label	CalcType	Units	Avg	Max	Min	Avg/Min	Max/Min
main parking spaces	Illuminance	Fc	1.71	4.0	0.7	2.44	5.71
rear parking spaces	Illuminance	Fc	2.05	2.6	1.6	1.28	1.63

NOTES:
1. ILLUMINANCE LEVELS TAKEN ON THE PAVEMENT
2. DARK BRONZE FINISH
3. TYPE-SA OVERALL MOUNTING HEIGHT:
16' POLE + 2' CONCRETE BASE = 18' A.F.G.

PHOTOMETRIC STUDY
Scale: 1" = 30' - 0"

Revisions				
#	Date	Comments		

Drawn By:	Checked By:	Date: 7/23/2026	Scale: