


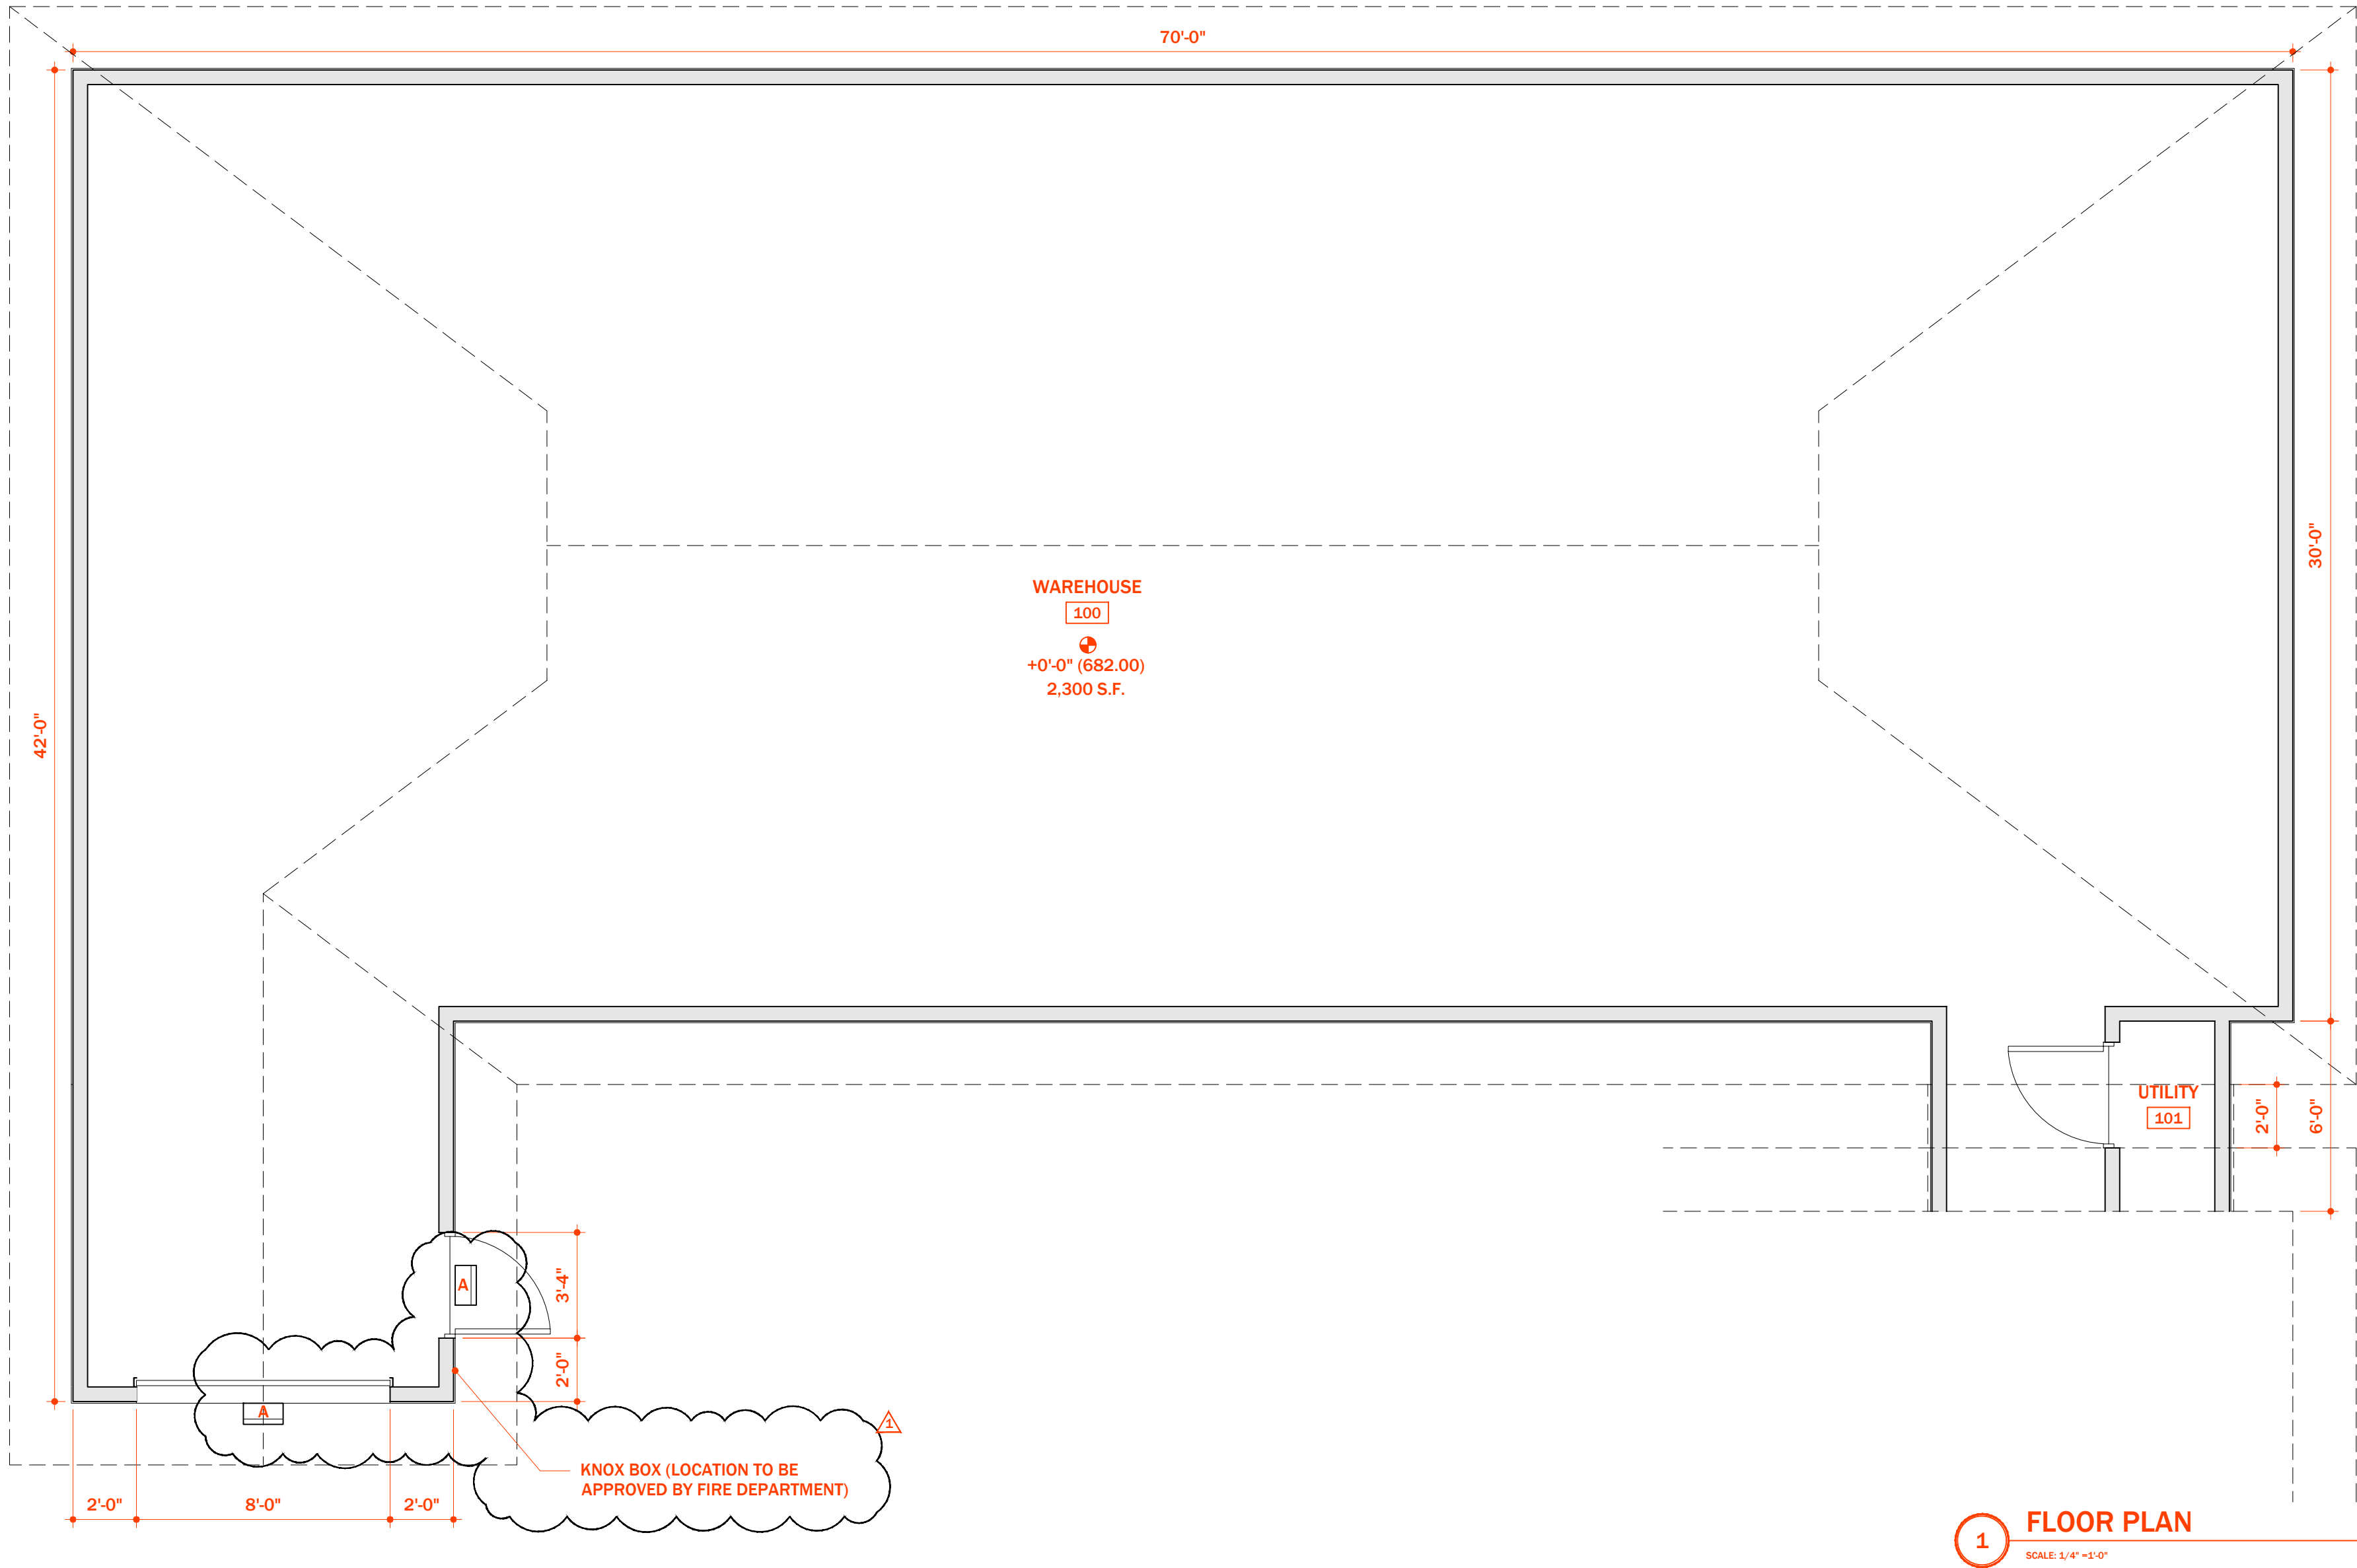

LIGHT FIXTURE SCHEDULE	
	FIXTURE A:
	INVUE ARCHITECTURAL WALL LUMINAIRE BY COOPER LIGHTING SOLUTIONS
	ORDERING INFORMATION:
ENC SA1C 735 1 T2 BK	

new storage building for:
INCH CREATIVE
27850 detroit road, westlake, ohio 44145

Project No. 2026.01

DATE ISSUED

Revisions	
CLIENT REVIEW	2026 0405
CLIENT REVIEW	2026 0426
FINAL DEVELOPMENT PLAN	2026 0803

Notes

A | R
ARCHITECT, LLC

Project North

Scale 1/4"=1'-0"

Floor Plan

A1.0

Sheet No. © 2026