


Project:

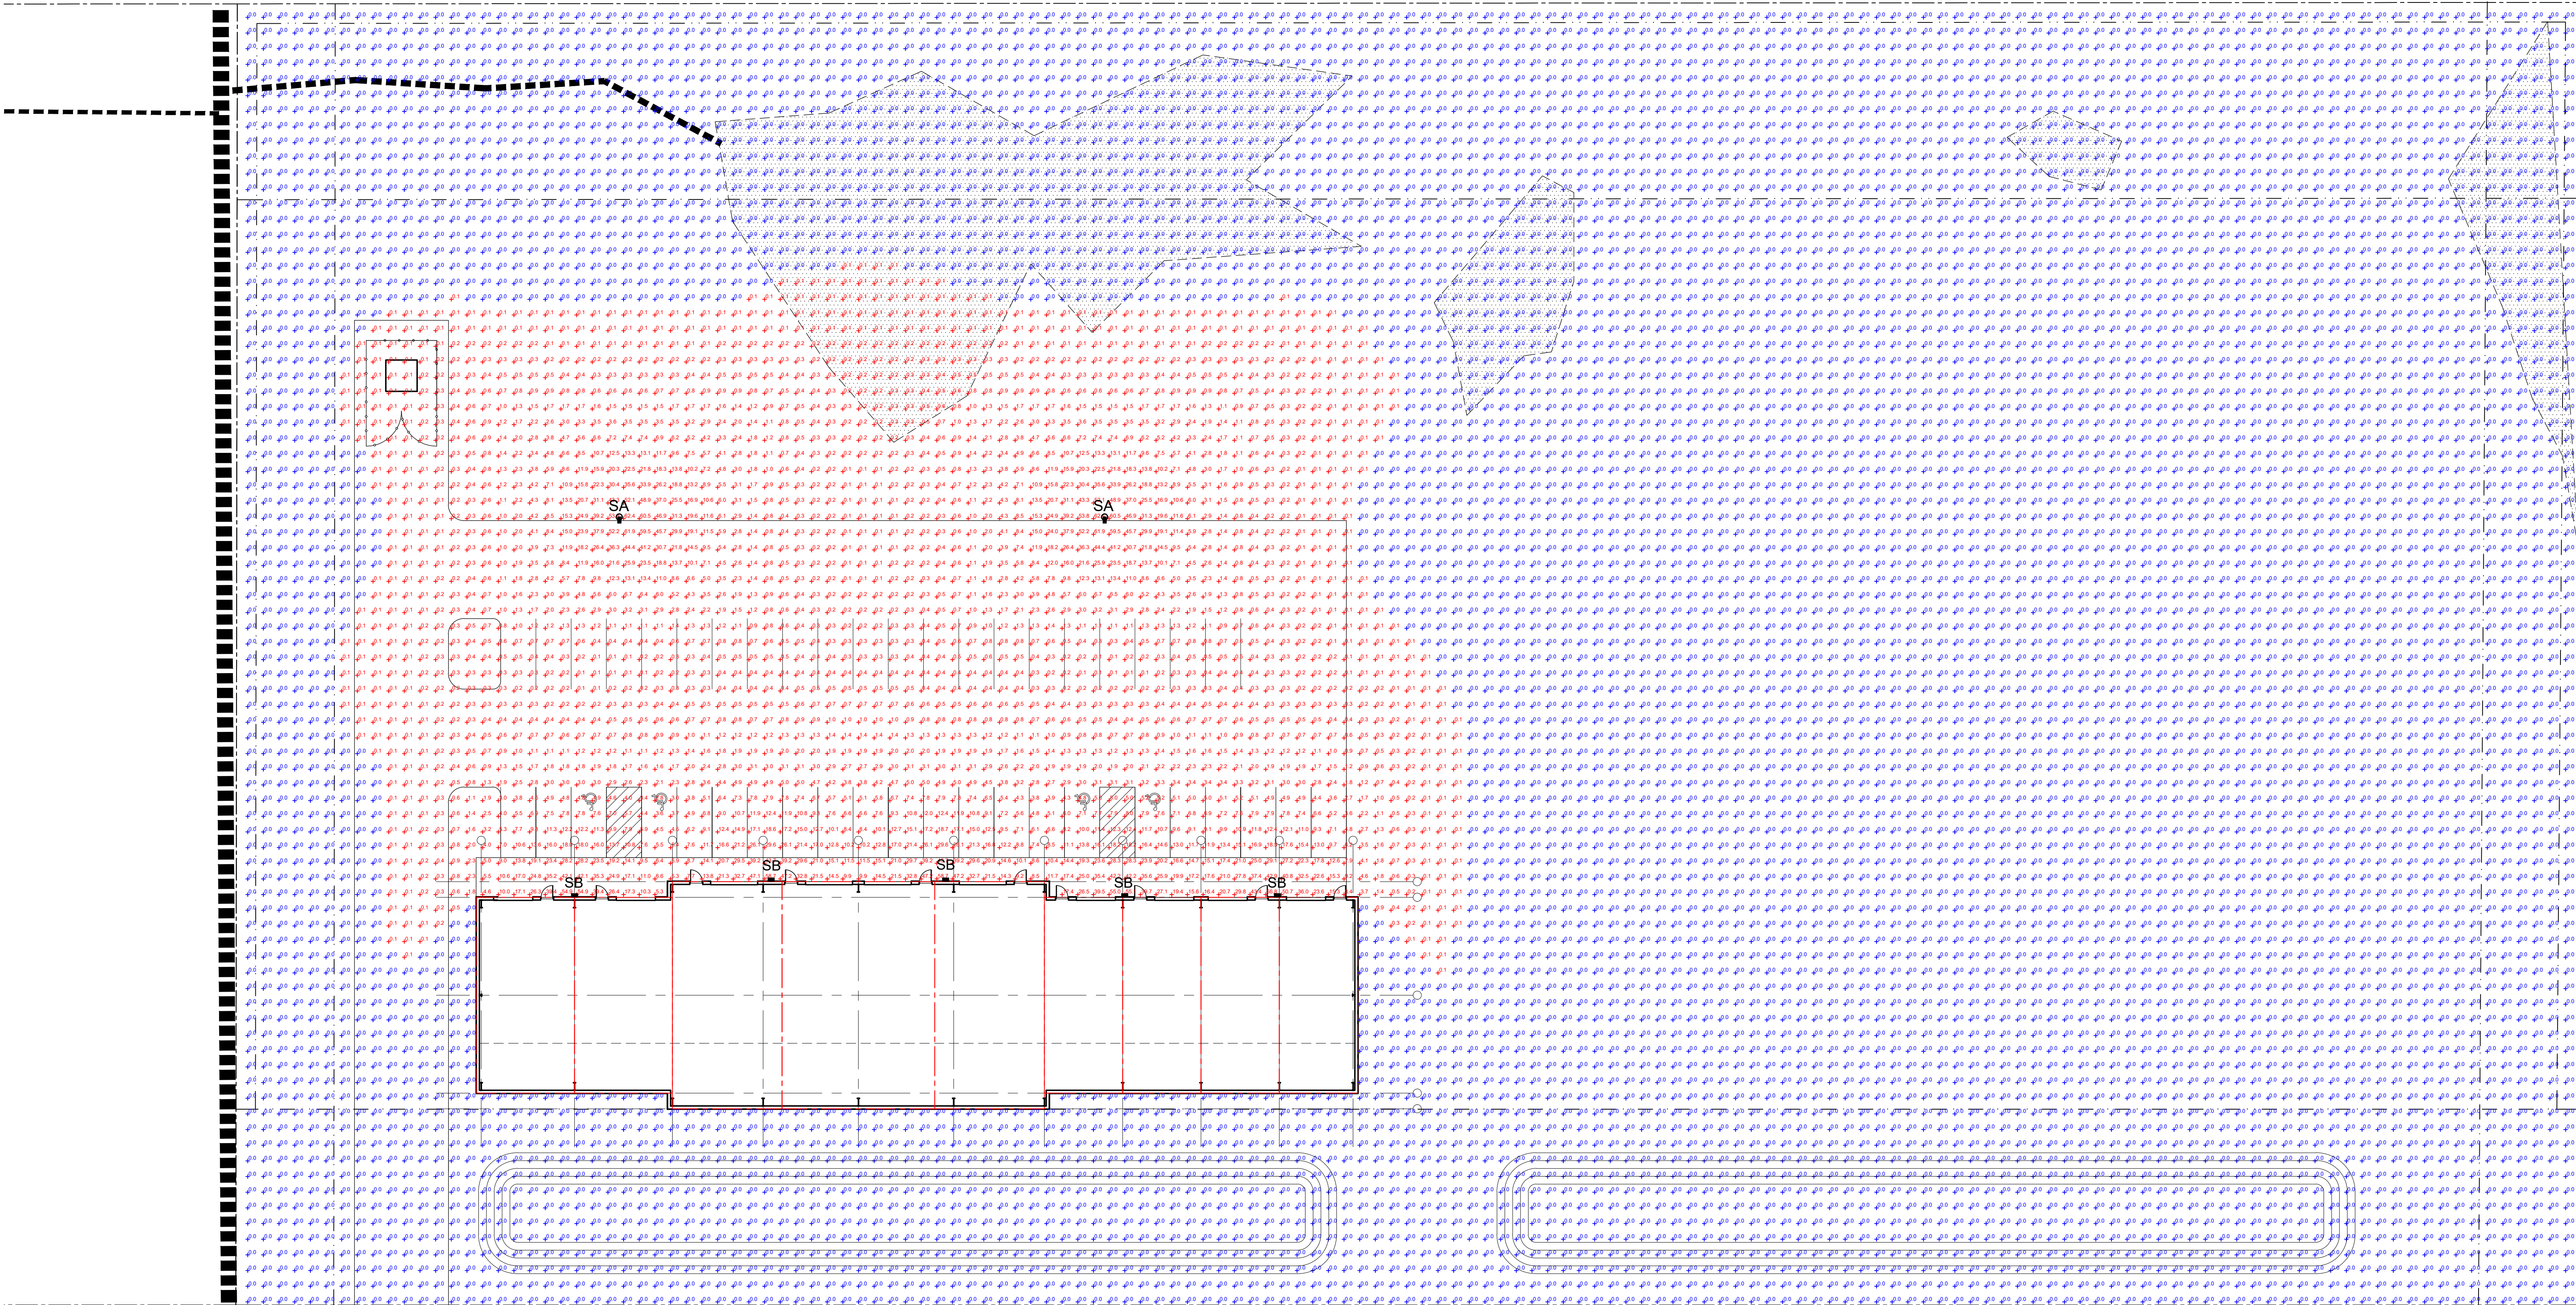

**L7 GROUP**  
**WESTLAKE FLEX CONDOS**

Issuance:

Planning Commission 03.04.2026  
Planning Commission 04.29.2026

Project Address:

**RANNEY PARKWAY**  
**WESTLAKE, OH 44145**

Project Number:

**26.06**

Sheet Title:

**PHOTOMETRIC PLAN**

Sheet Number:

**PH101**

LIGHTING FIXTURE SCHEDULE				
TYPE	MGF.	CAT. NO.	VOLT.	DESCRIPTION
SA	LITHONIA	EAX3 P5 50K T5 HS	UNV	SINGLE 210W LED HEADS MOUNTED TO 20' SQUARE ALUMINUM POLE, BLACK FINISH, EAX3 AREA LUMINAIRE ALO PACKAGE (MAX DEFAULT SETTINGS) 5000K CCT TYPE 5 HOUSE SIDE SHIELD (1-SIDED BACK ONLY)
SB	LITHONIA	WDGE4 LED P6 50K 70CRI RFT	UNV	WDGE4 LED WITH P6 - PERFORMANCE PACKAGE, 5000K, 70CRI, FORWARD THROW OPTIC

1  
PH101

**PHOTOMETRIC PLAN**  
SCALE: 1" = 20'-0"

