


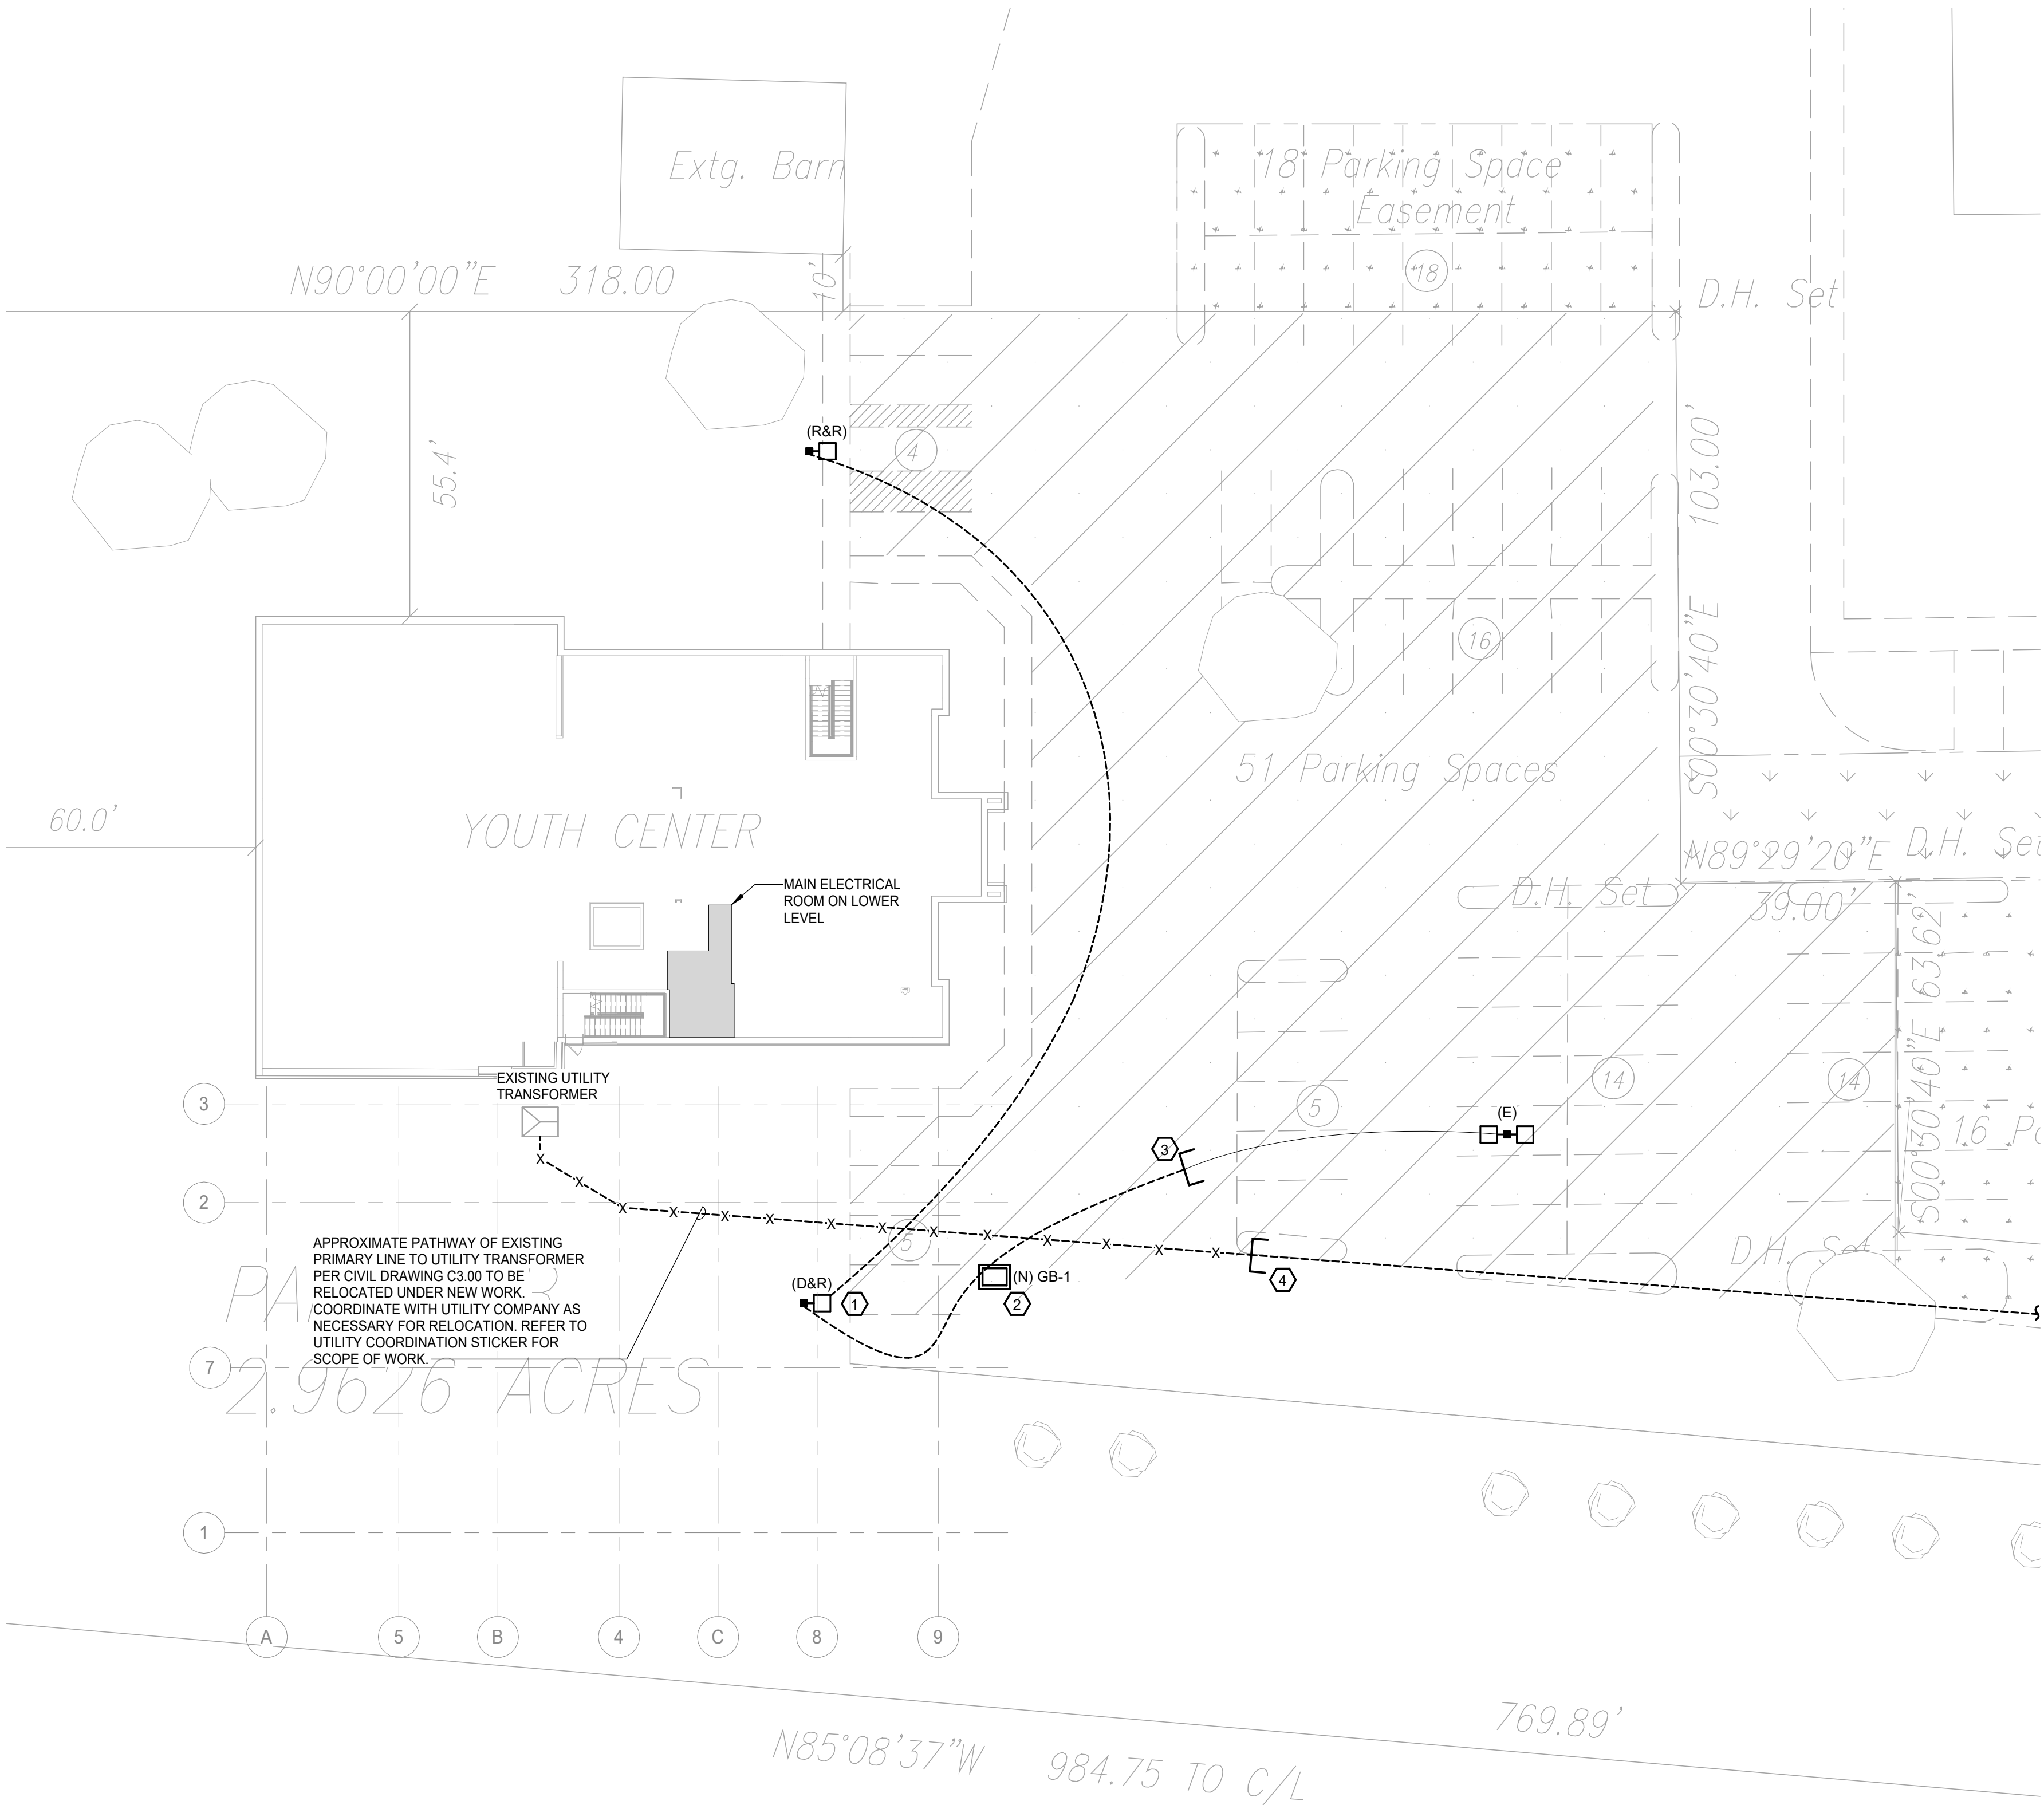

GENERAL SHEET NOTES:

- FOR ANY WIRES THAT REMAIN IN JUNCTION BOXES, LABEL THE SOURCE AND CAP WIRES.
- IN AREAS OF DEMOLITION WHERE EXISTING BRANCH CIRCUITS ARE TO BE RE-USED FOR NEW WORK, CAP ALL DISCONNECTED ELECTRICAL CIRCUITRY IN JUNCTION BOXES ABOVE ACCESSIBLE CEILINGS, WITHIN EXISTING WALLS, ETC. AND MAINTAIN FOR EXTENSION.
- REFER TO NEW WORK DRAWINGS FOR ADDITIONAL INFORMATION AND REQUIREMENTS.
- REFER TO SHEET E2.00 FOR REROUTING OF INCOMING PRIMARY TO UTILITY TRANSFORMER.

SHEET KEY NOTES:

- DISCONNECT AND REMOVE EXISTING LIGHTING POLE TO BE REUSED UNDER NEW WORK. PULL SITE LIGHTING BRANCH CIRCUIT BACK TO LAST ACTIVE DEVICE TO REMAIN.
- PROVIDE BOTTOMLESS GROUND BOX 12" X 18" AND CAST IRON LID LABELED "LIGHTING" TO INTERCEPT SITE LIGHTING BRANCH CIRCUIT. MATCH EXISTING CONDUIT AND WIRING SIZE.
- EXISTING BRANCH CIRCUIT ROUTING TO BE VERIFIED ON SITE. INTERCEPT EXISTING LIGHTING BRANCH CIRCUITING.
- EXISTING BRANCH CIRCUIT ROUTING TO BE VERIFIED ON SITE. INTERCEPT EXISTING POWER BRANCH CIRCUITING.



Julie Billiard School
Julie Billiard Westlake Expansion

3600 Crocker Rd.
Westlake, OH 44145



Issue Description: DEVELOPMENT PLANS		
Revision Schedule		
#	DATE	DESCRIPTION

Project #: 25058
Issue Date: 08/12/2026

ED2.00

SITE ELECTRICAL
DEMOLITION PLAN

1

LEVEL 1 - SITE PLAN DEMOLITION

SCALE: 1" = 20'-0"

