


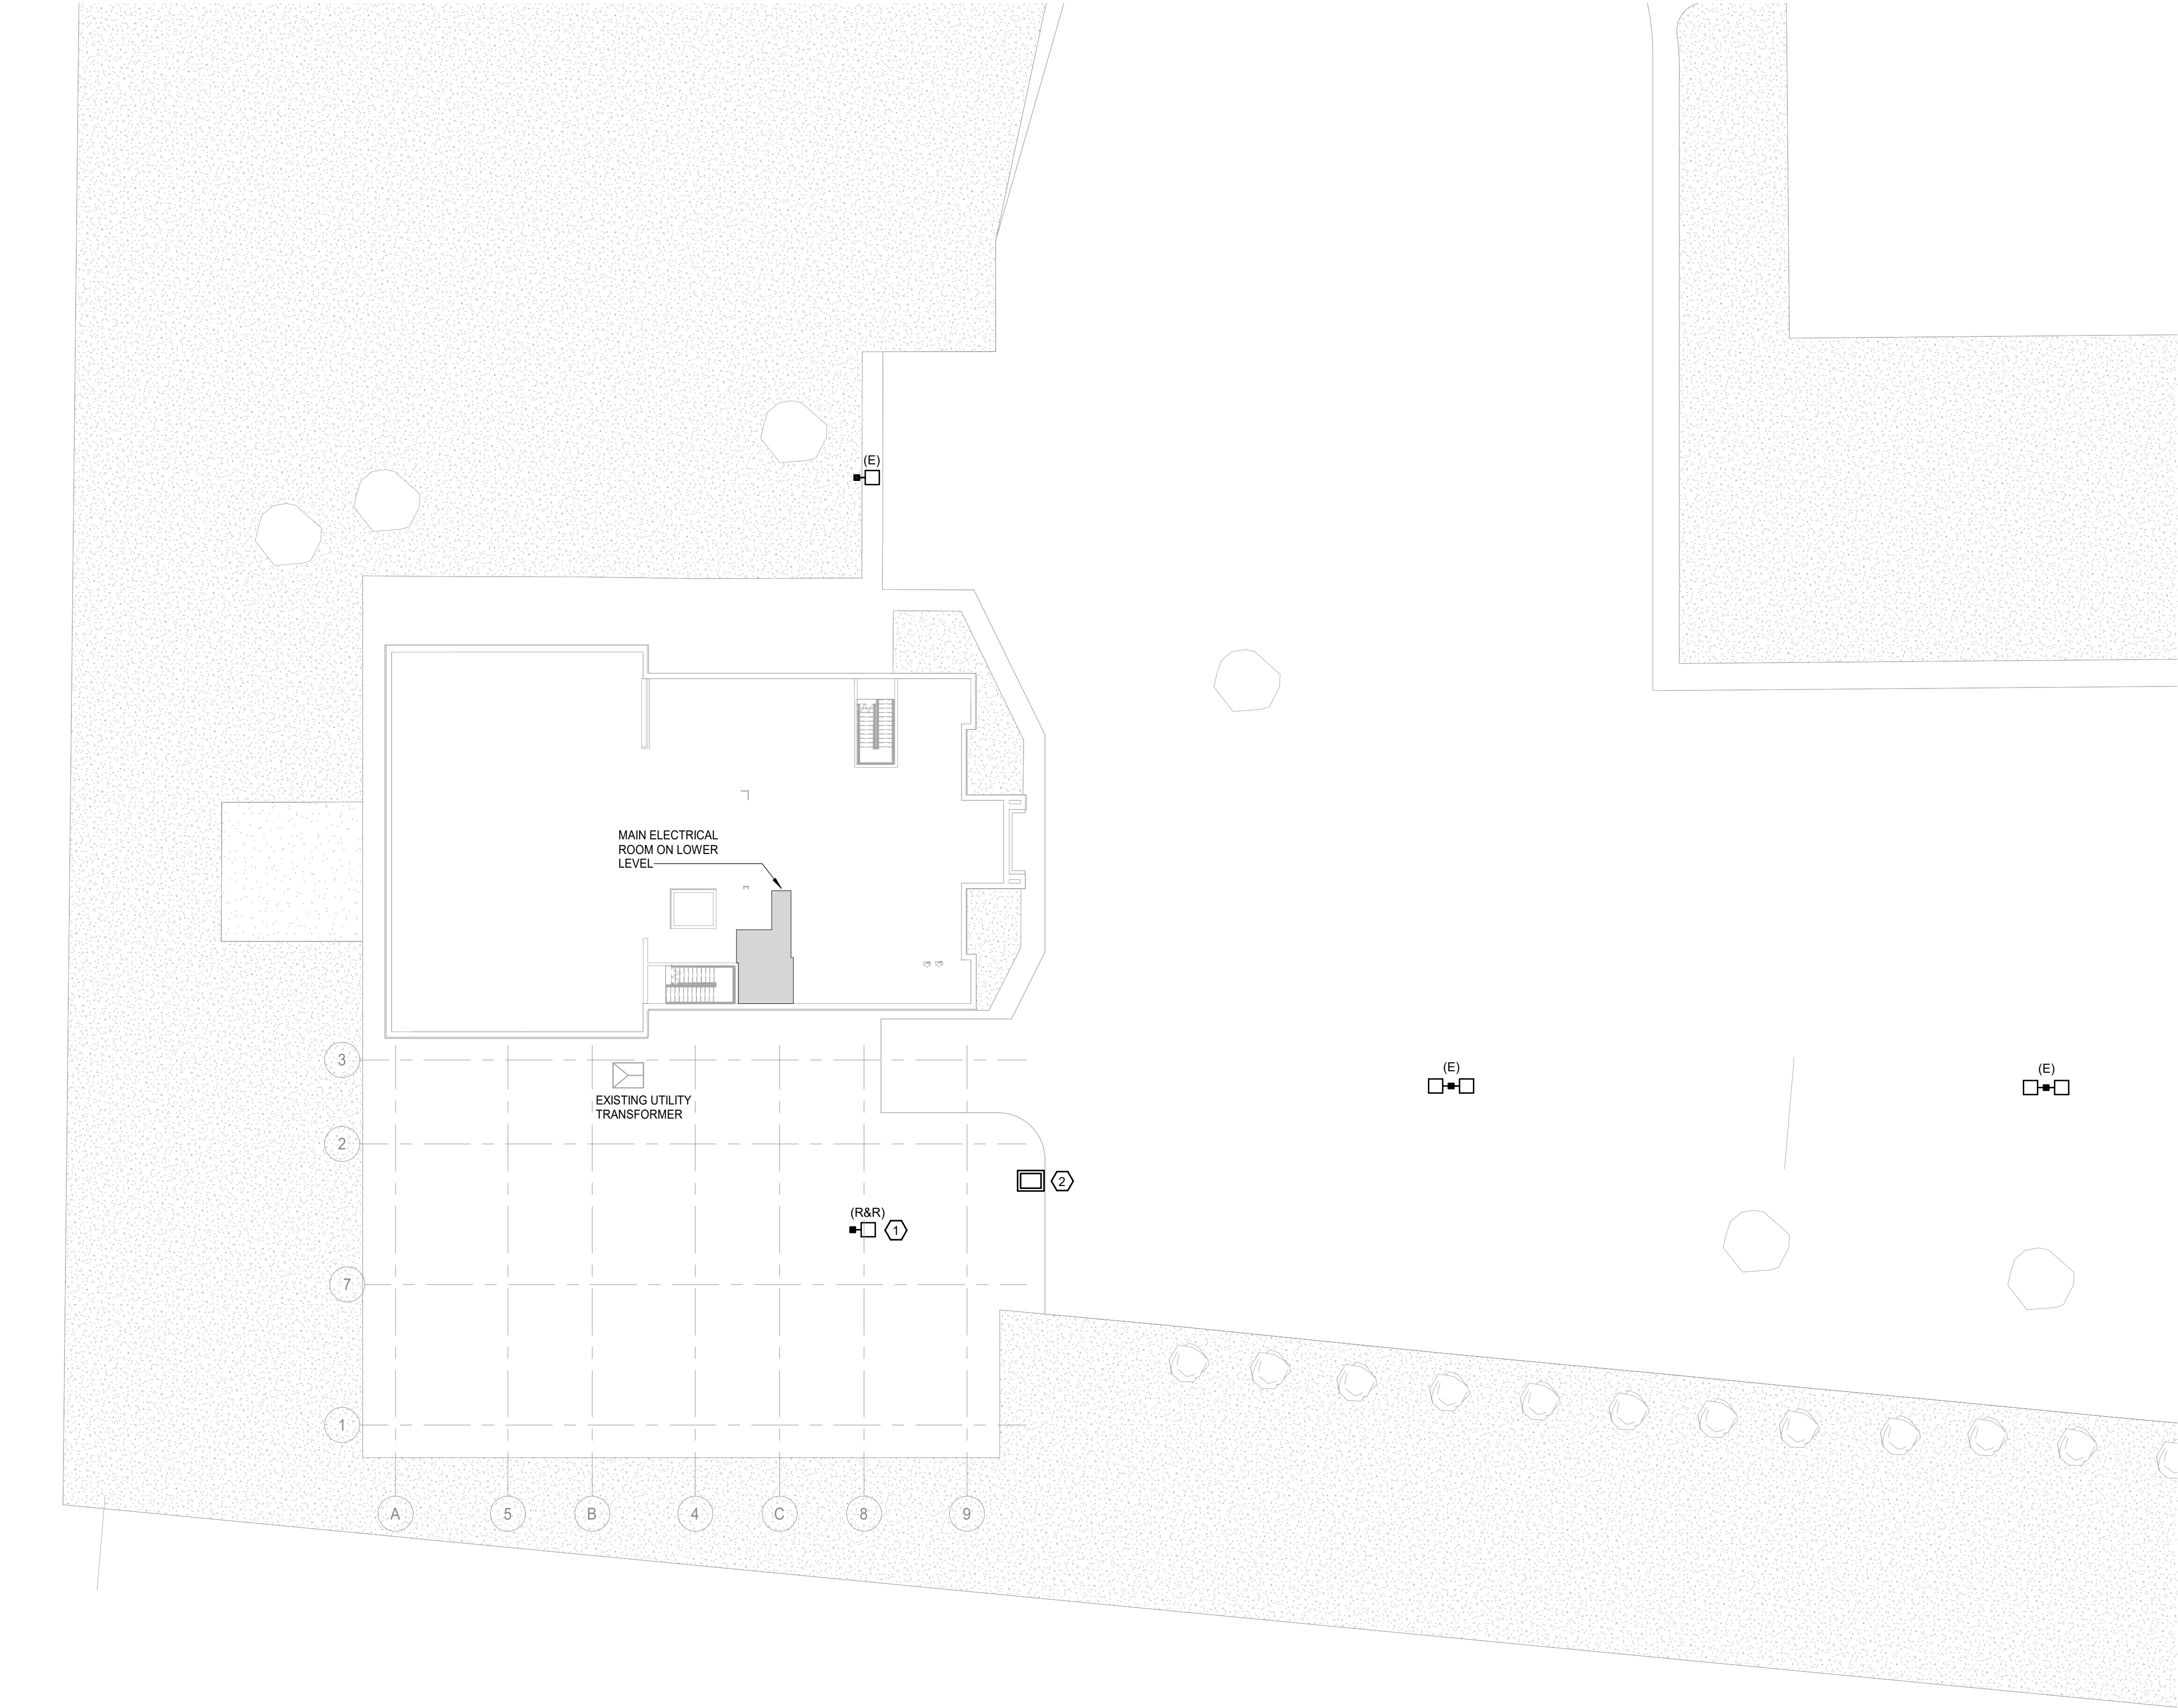

1 LEVEL 1 - SITE PLAN DEMOLITION
SCALE: 1" = 20'-0"



GENERAL SHEET NOTES:

1. FOR ANY WIRES THAT REMAIN IN JUNCTION BOXES, LABEL THE SOURCE AND CAP WIRES.
2. IN AREAS OF DEMOLITION WHERE EXISTING BRANCH CIRCUITS ARE TO BE RE-USED FOR NEW WORK, CAP ALL DISCONNECTED ELECTRICAL CIRCUITRY IN JUNCTION BOXES ABOVE ACCESSIBLE CEILINGS, WITHIN EXISTING WALLS, ETC. AND MAINTAIN FOR EXTENSION.
3. REFER TO NEW WORK DRAWINGS FOR ADDITIONAL INFORMATION AND REQUIREMENTS.

SHEET KEY NOTES:

1. DISCONNECT AND REMOVE EXISTING LIGHTING POLE TO BE REUSED UNDER NEW WORK. PULL SITE LIGHTING BRANCH CIRCUIT BACK TO LAST ACTIVE DEVICE TO REMAIN.
2. PROVIDE BOTTOMLESS GROUND BOX 12" X 18" TO INTERCEPT SITE LIGHTING BRANCH CIRCUIT. MATCH EXISTING CONDUIT AND WIRING SIZE.



Julie Billiart School
Julie Billiart Westlake Expansion

3600 Crocker Rd,
Westlake, OH 44145



Issue Description: DESIGN DOCUMENTS		
Revision Schedule		
#	DATE	DESCRIPTION

Project #:	25058
Issue Date:	5/15/2026

ED2.00

SITE ELECTRICAL
DEMOLITION PLAN