


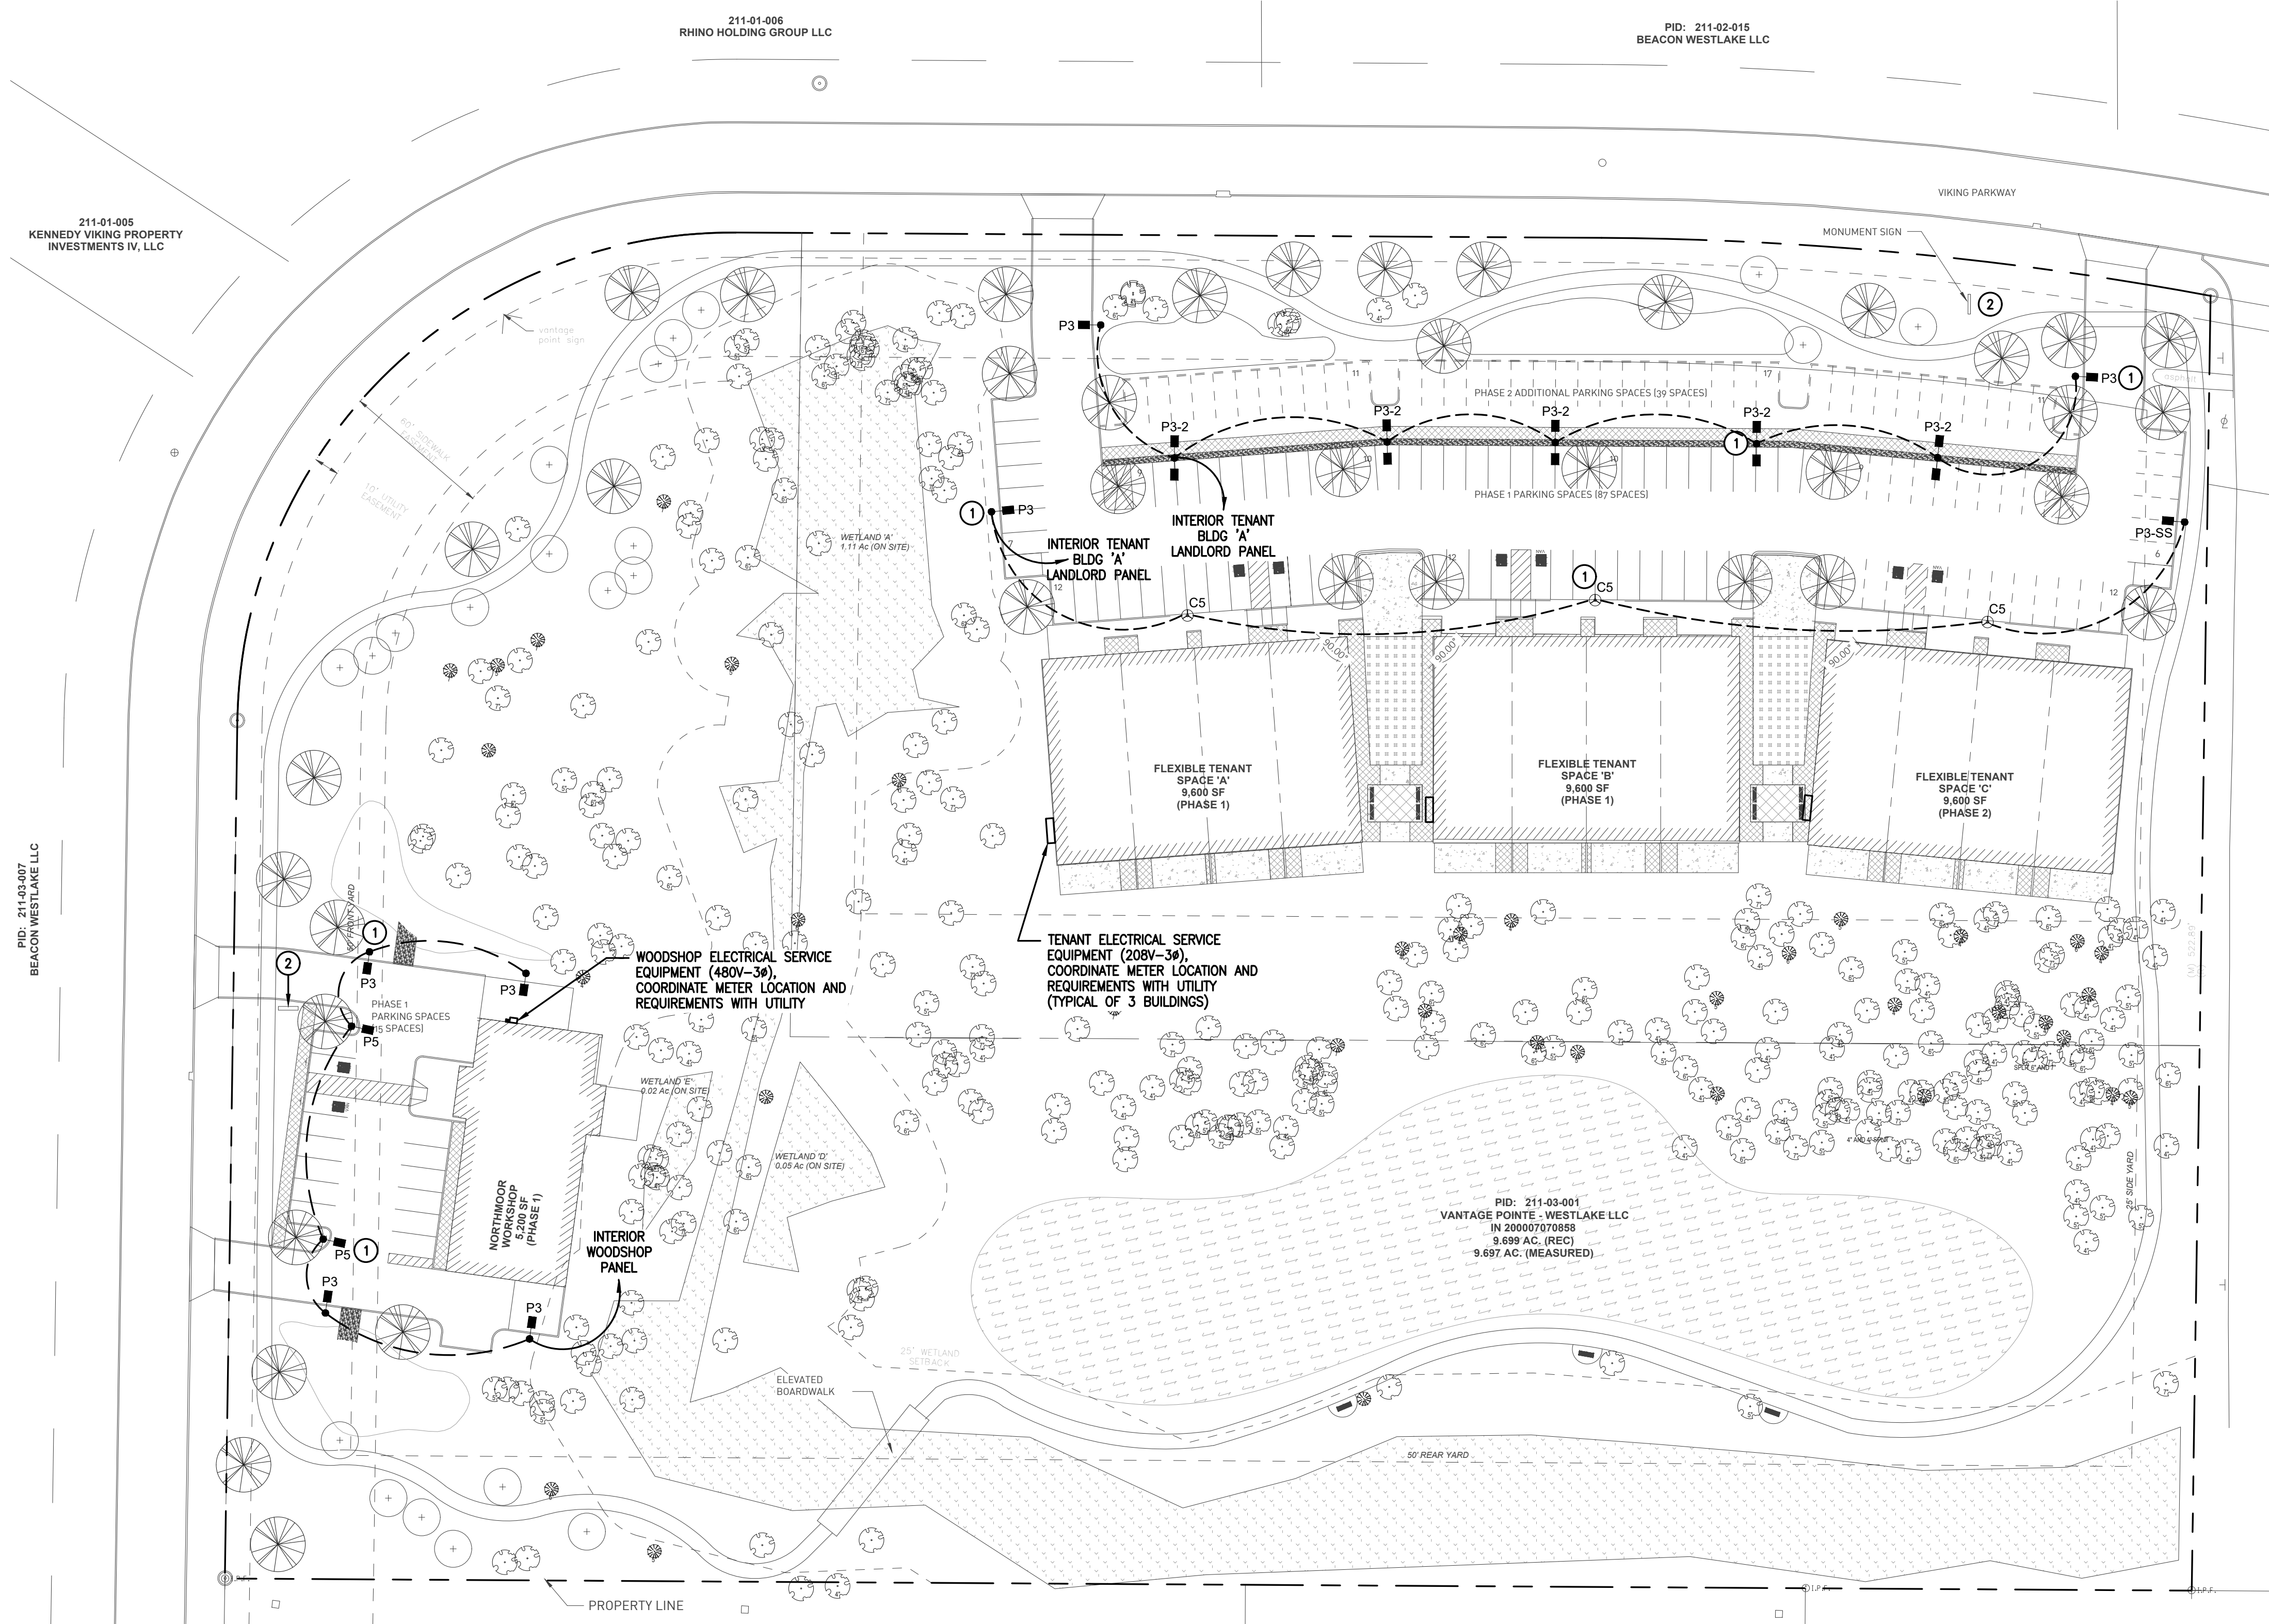


SITE PLAN GENERAL NOTES

1. VERIFY EXISTING SITE CONDITIONS, SERVICE REQUIREMENTS, AND EXACT LOCATIONS OF SERVICE FACILITIES BEFORE SUBMITTING BID.
2. ELECTRICAL CONTRACTOR SHALL FURNISH TEMPORARY CONSTRUCTION POWER – COORDINATE WITH G.C.
3. ALL SITE BRANCH CIRCUIT CONDUCTORS SHALL BE 10-AWG THWN-2 CU, U.N.O.
4. MINIMUM SITE CONDUIT SIZE SHALL BE 1" U.N.O. PROVIDE PULL-WIRE IN ALL CONDUIT ONLY RUNS. USE RGS WHERE EXPOSED AND SUBJECT TO PHYSICAL ABUSE. PROVIDE SCH-40 PVC BELOW GRADE OR UNDER GROUND. TRANSITION TO RGS PRIOR TO TURNING UP OR ENTERING BUILDING, STRUCTURES OR EQUIPMENT.
5. COORDINATE IN FIELD, ELECTRICAL SERVICE, TELEPHONE, CABLE TV, AND SIMILAR SERVICE ROUTINGS, EQUIPMENT LOCATIONS & INSTALLATION REQUIREMENTS.

CODED PLAN NOTES

- ① POLE MOUNTED FIXTURE, PROVIDE CIRCUITING AS SHOWN. REFER TO SHEET #ES100 FOR SITE LIGHTING SPECIFICATIONS AND POLE BASE DETAIL ON THIS SHEET FOR MOUNTING HEIGHT. COORDINATE EXACT POLE LOCATION IN FIELD WITH PROJECT MANAGER PRIOR TO ROUGH-IN. (TYPICAL)
- ② SITE GROUND SIGN. PROVIDE (2) 1" UNDERGROUND CONDUITS WITH PULLWIRE STUBBED BACK TO INTERIOR ELECTRICAL ROOM. COORDINATE POWER REQUIREMENTS AND FINAL LOCATION WITH EQUIPMENT MANUFACTURER AND P.M. PRIOR TO ROUGH-IN.

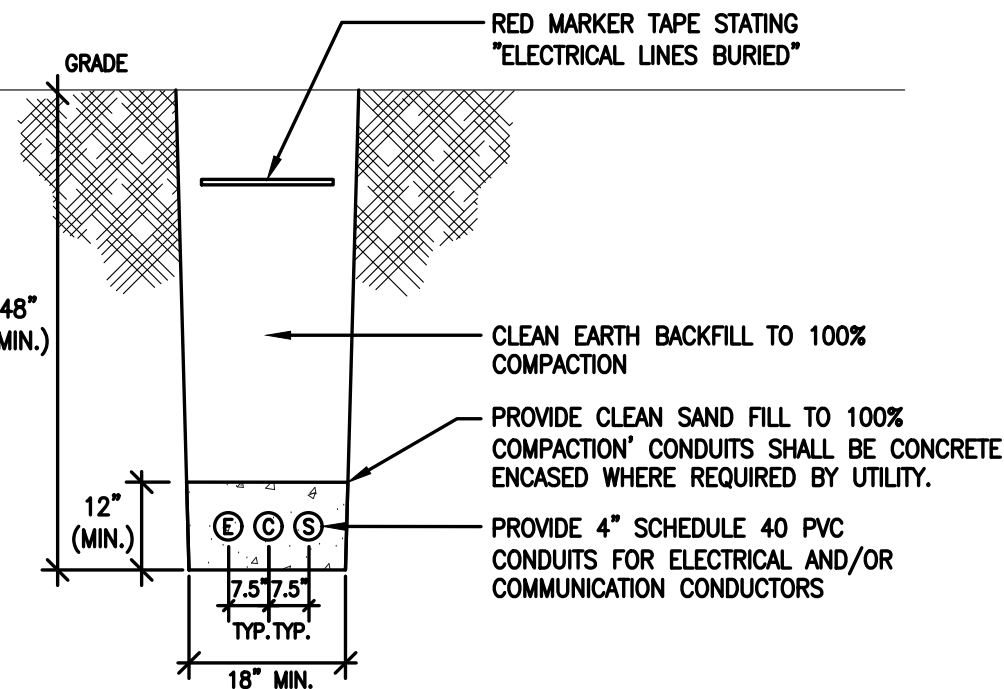


TYPICAL TRENCH SECTION DETAIL

NO SCALE

TRENCH SECTION CONDUIT LEGEND:

- "C" 4" COMMUNICATION CONDUIT WITH PULLWIRE
- "E" ELECTRICAL SERVICE CONDUCTORS (SEE SINGLE LINE RISER DIAGRAM)
- "S" SPARE CONDUIT W/ PULLWIRE

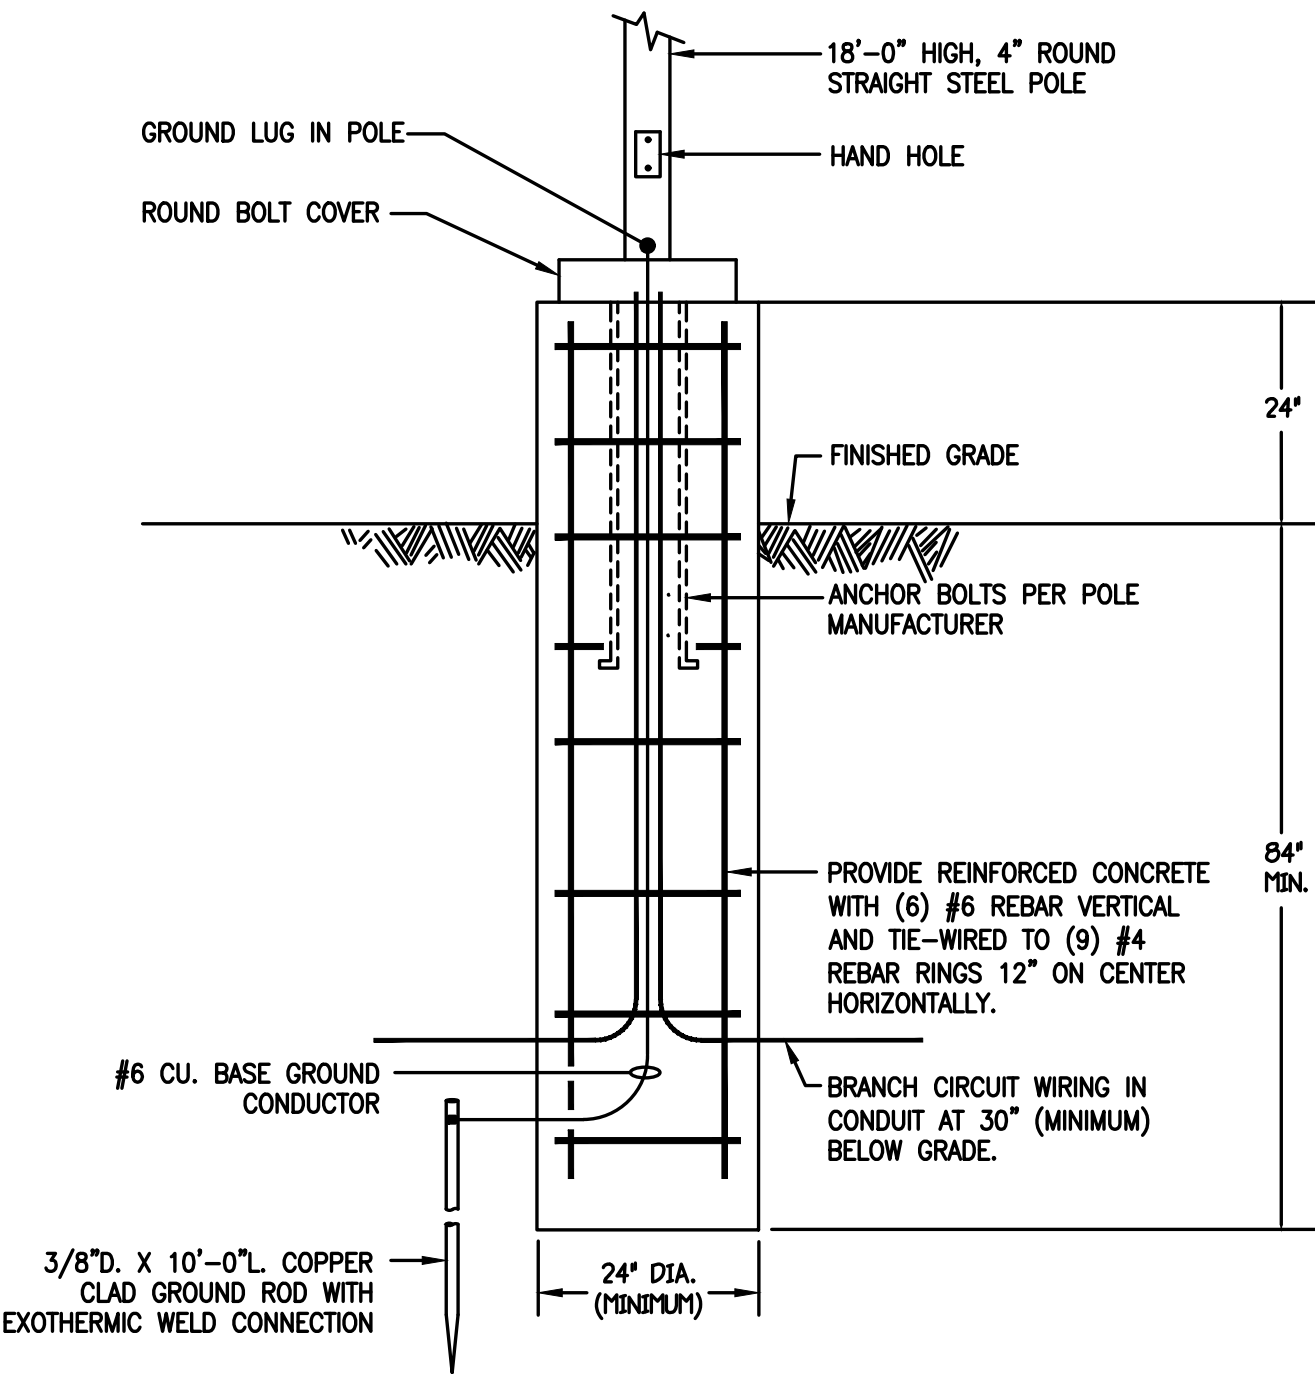

POLE BASE DETAIL

NO SCALE



who
engineering
2102 West 25th Street, Suite 900
Cleveland, OH 44113
Phone: 216 227 8505

VIKING PARKWAY
NORTHMOOR WOODWORKS & STUDIOS

PROJECT ADDRESS:	
3100 VIKING PARKWAY WESTLAKE, OH 44145	
ISSUE DESCRIPTION	
SD Coordination Set	07.02.26
SD Pricing Set	07.24.26
ISSUE DATE:	
25.19	
SHEET TITLE:	
ELECTRICAL SITE PLAN	
SHEET NO.:	
ES101	

THESE DRAWINGS, DESIGN, CONCEPT AND INFORMATION ARE THE EXCLUSIVE PROPERTY OF AODK, INC. THEY ARE FOR CONSTRUCTION ONLY AT THE SITE INDICATED.

UNAUTHORIZED USE, ALTERATION OR REPRODUCTION OF THE DOCUMENTS AND DESIGN IS PROHIBITED WITHOUT WRITTEN PERMISSION FROM AODK, INC.